

Table of Contents

- A0 - Cover Sheet
- A1- Basement Plan
- A2 - First Floor Plan
- A3 - Second Floor Plan
- A4 - First Floor
Dimensions
- A5 - Second Floor
Dimensions
- A6 - Roof Plan
- A7 - Elevations -
North/South
- A8 - Elevations -
East/West
- A9 - Basement
Dimensions
- A10 - Wall Section
- A11 - Schedules
- A12 - Site Plan
- A13 - Foundation Plan



www.autodesk.com/revit

Consultant
Address
Phone
Fax
e-mail

Consultant
Address
Phone
Fax
e-mail

Consultant
Address
Phone
Fax
e-mail

Consultant
Address
Phone
Fax
e-mail

Consultant
Address
Phone
Fax
e-mail

No.	Description	Date

Cayley Quinn
Project Name
Cover Sheet

Project number CGT 262 Final Project
Date 12/06/2019
Drawn by Cayley
Checked by Checker

A0

Scale



www.autodesk.com/revit

Consultant
Address
Phone
Fax
e-mail

Consultant
Address
Phone
Fax
e-mail

Consultant
Address
Phone
Fax
e-mail

Consultant
Address
Phone
Fax
e-mail

Consultant
Address
Phone
Fax
e-mail

No.	Description	Date

Cayley Quinn
Project Name
Basement Plan

Project number CGT 262 Final Project

Date 12/06/2019


Drawn by Author

Checked by Checker

A1

Scale 3/16" = 1'-0"

12/30/19 11:46:25 AM

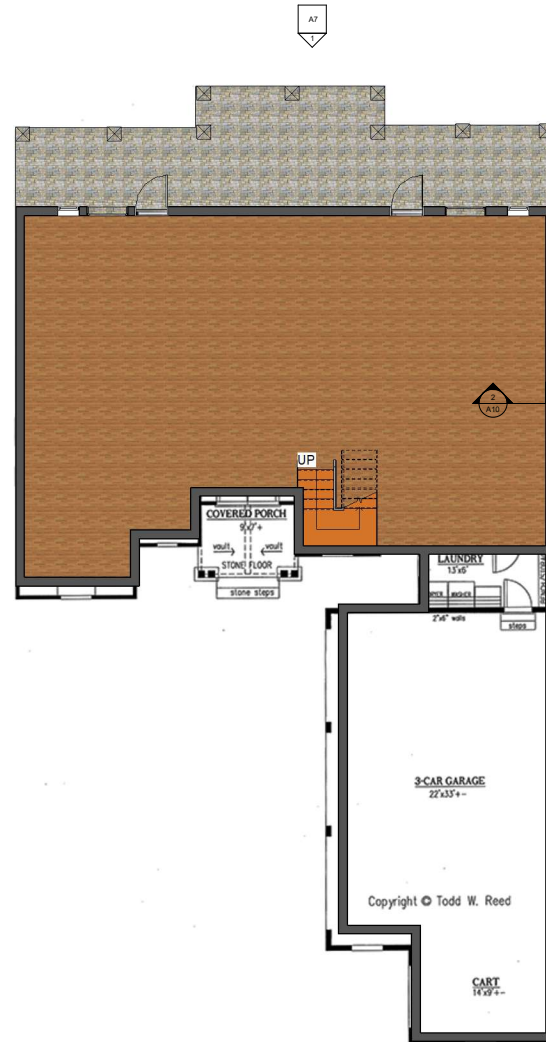

A8

A8

A7

A7



A2

A2

A7



www.autodesk.com/revit

Consultant
Address
Phone
Fax
e-mail

Consultant
Address
Phone
Fax
e-mail

Consultant
Address
Phone
Fax
e-mail

Consultant
Address
Phone
Fax
e-mail

Consultant
Address
Phone
Fax
e-mail

No.	Description	Date


Cayley Quinn
Project Name
First Floor Plan

Project number CGT 262 Final Project
Date 12/06/2019
Drawn by Author
Checked by Checker

A2

Scale 3/16" = 1'-0"

12/06/2019 11:46:27 AM

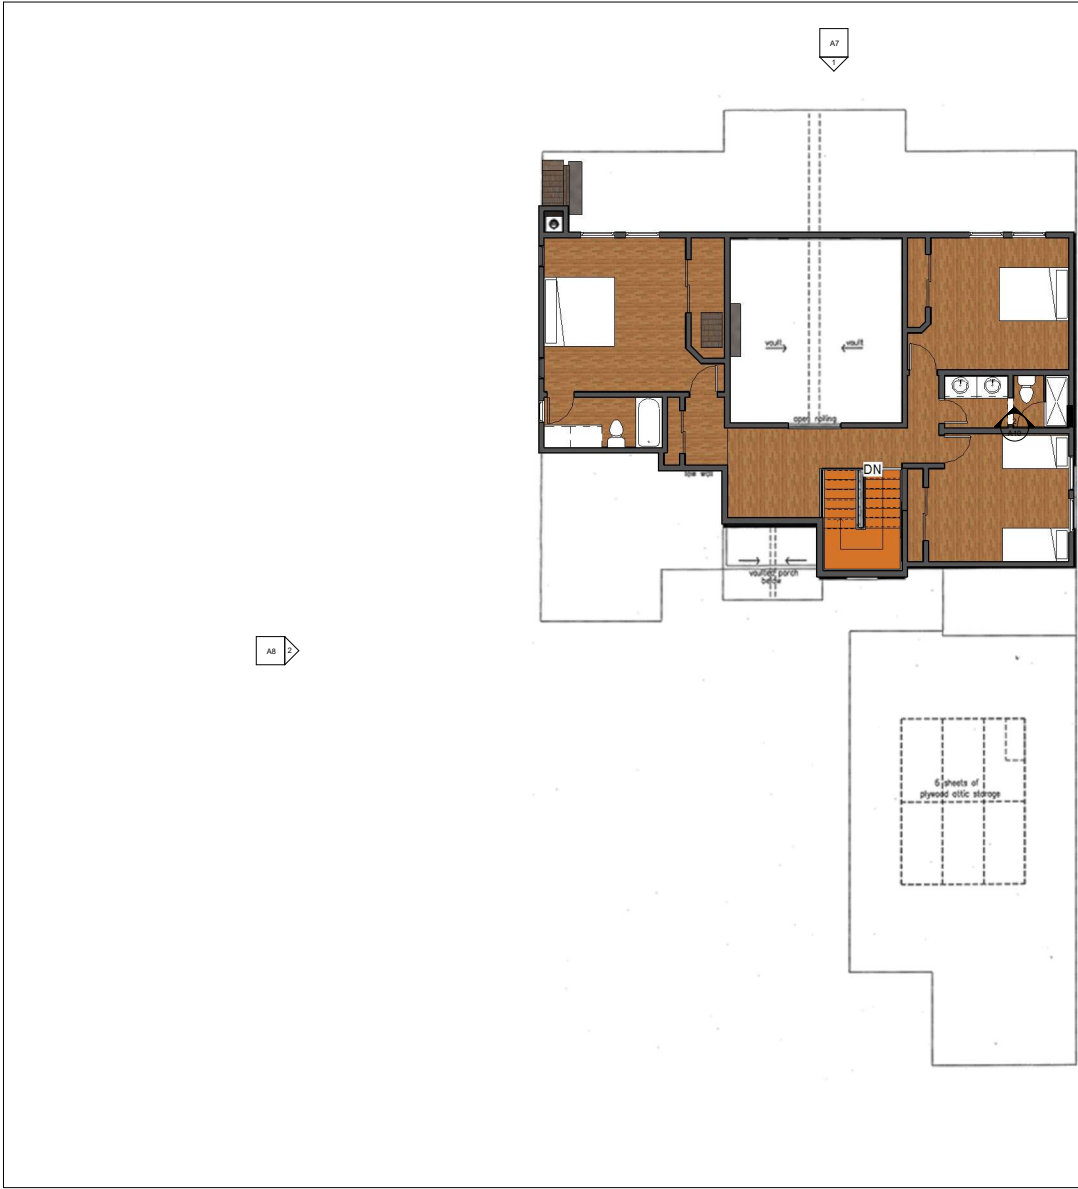

www.autodesk.com/revit

Consultant Address Phone Fax e-mail
Consultant Address Address Phone Fax e-mail
Consultant Address Address Phone Fax e-mail
Consultant Address Address Phone Fax e-mail
Consultant Address Address Phone Fax e-mail


No.	Description	Date

Cayley Quinn
 Project Name
 Second Floor Plan

Project number CGT 262 Final Project
 Date 12/06/2019
 Drawn by Author
 Checked by Checker

A3

Scale 3/16" = 1'-0"

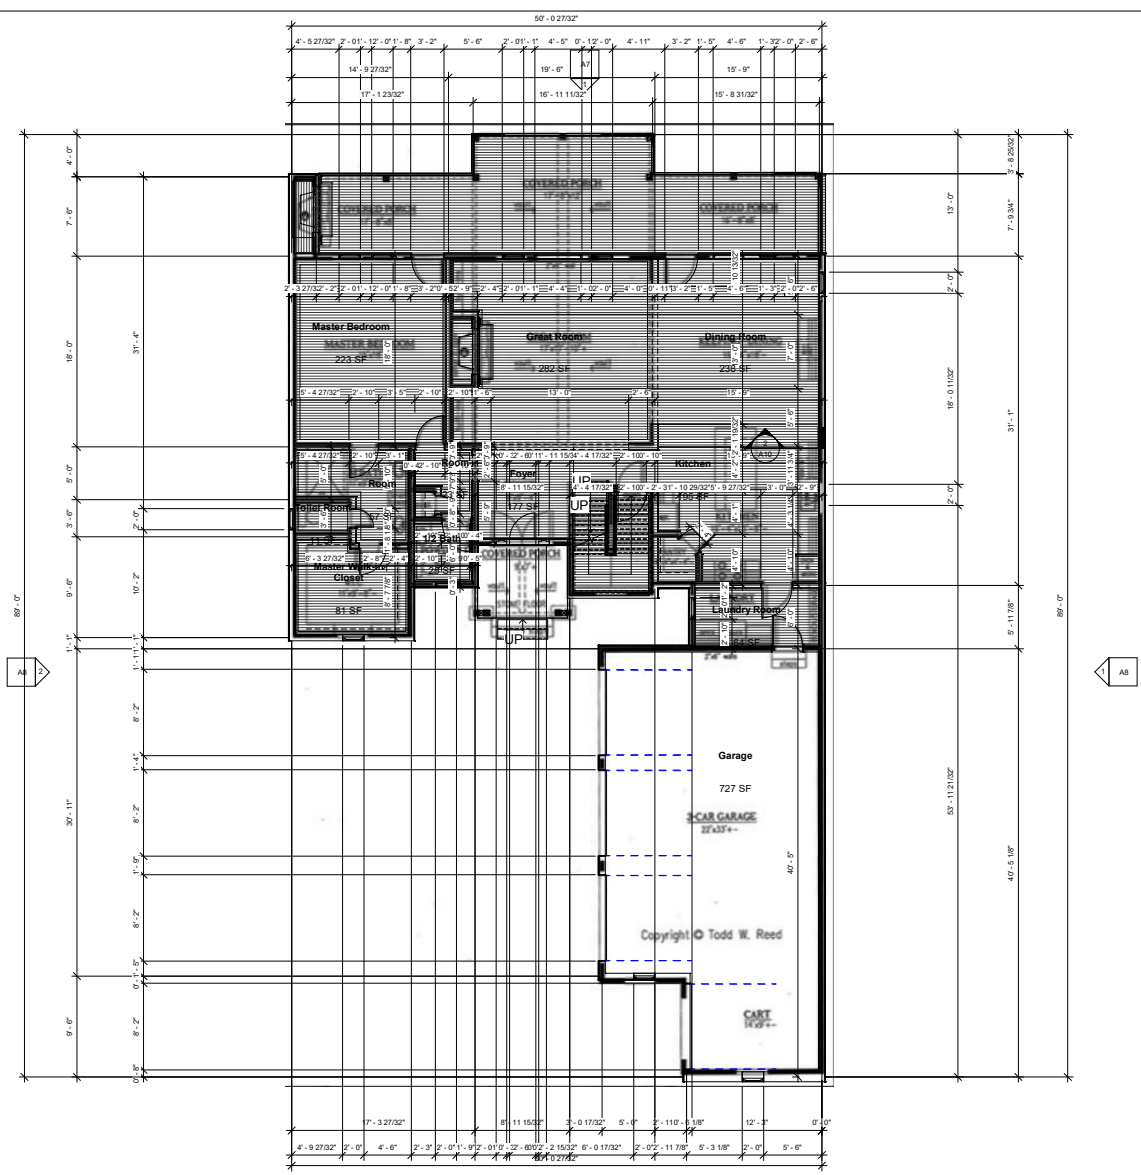

www.autodesk.com/revit

Consultant Address Phone Fax e-mail
Consultant Address Phone Fax e-mail
Consultant Address Phone Fax e-mail
Consultant Address Phone Fax e-mail

No.	Description	Date

Cayley Quinn
Project Name
First Floor Dimensions

Project number: CGT 262 Final Project
 Date: 12/06/2019
 Drawn by: Author
 Checked by: Checker

A4

Scale: 3/16" = 1'-0"

12/06/2019 11:46:28 AM

Consultant
Address
Phone
Fax
e-mail

Consultant
Address
Phone
Fax
e-mail


Consultant
Address
Phone
Fax
e-mail

Consultant
Address
Phone
Fax
e-mail


Consultant
Address
Phone
Fax
e-mail

No.	Description	Date

Cayley Quinn	
Project Name	
Second Floor	
Dimensions	
Project number	CGT 262 Final Project
Date	12/06/2019
Drawn by	Author
Checked by	Checker
A5	
Scale	3/16" = 1'-0"

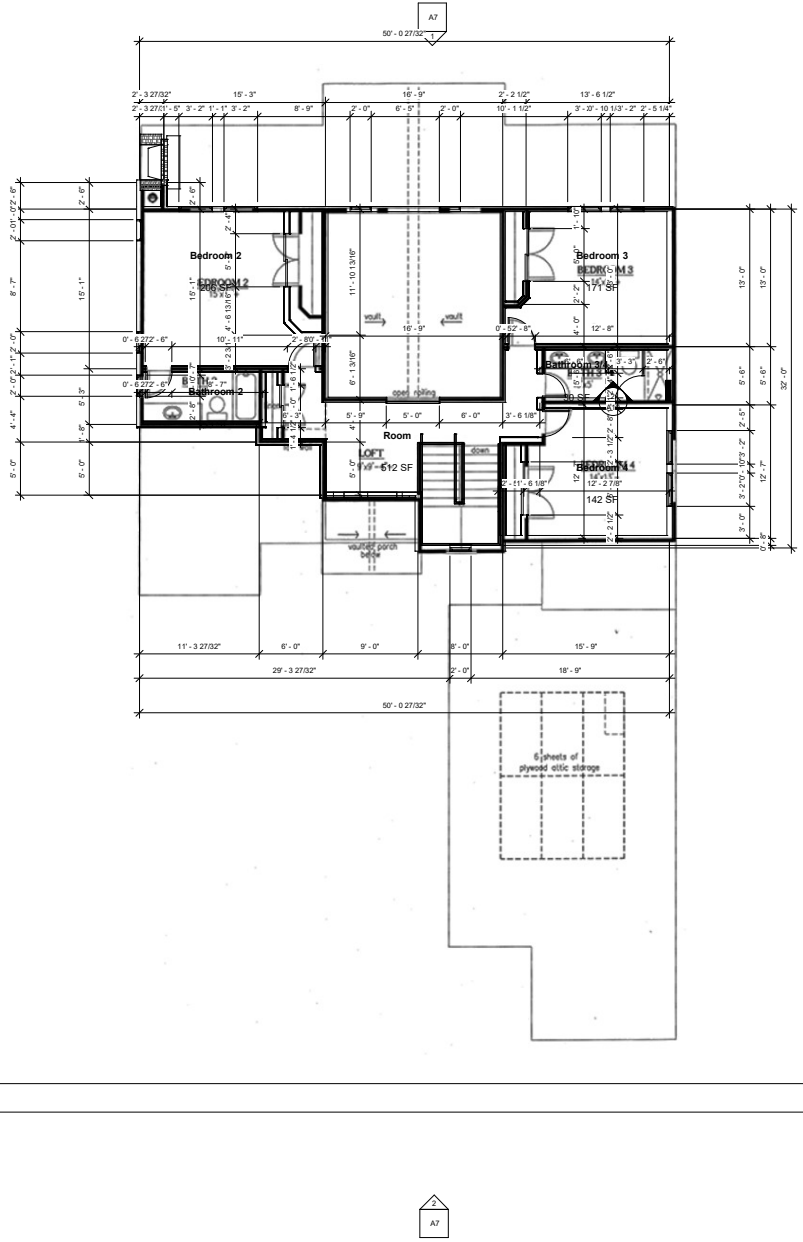

A7

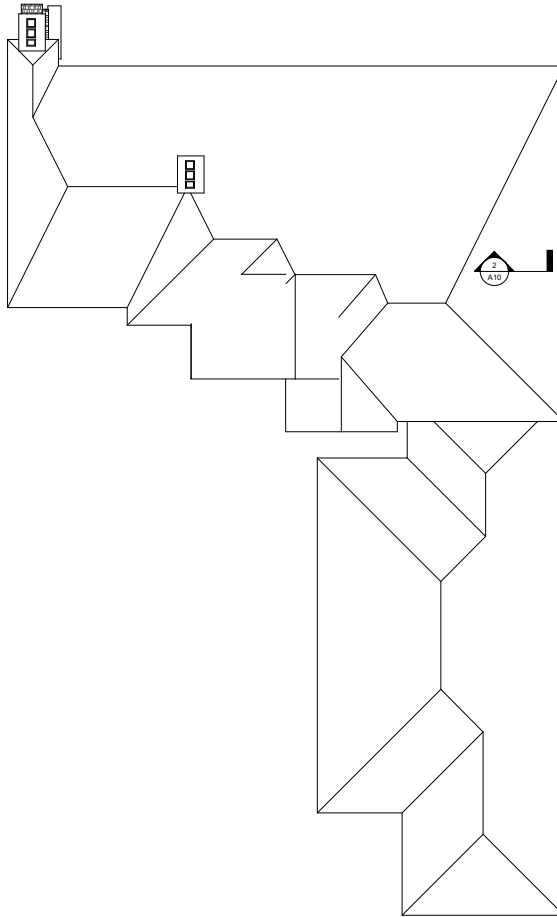

AB

AB

A7



www.autodesk.com/revit

Consultant
Address
Phone
Fax
e-mail

Consultant
Address
Phone
Fax
e-mail

Consultant
Address
Phone
Fax
e-mail

Consultant
Address
Phone
Fax
e-mail

Consultant
Address
Phone
Fax
e-mail

No.	Description	Date

Cayley Quinn
Project Name
Roof Plan

Project number CGT 262 Final Project

Date 12/06/2019

Drawn by Author

Checked by Checker

A6

Scale 3/16" = 1'-0"

12/06/2019 11:46:20 AM



www.autodesk.com/revit

Consultant
Address
Phone
Fax
e-mail

Consultant
Address
Phone
Fax
e-mail

Consultant
Address
Phone
Fax
e-mail

Consultant
Address
Phone
Fax
e-mail

No.	Description	Date



Cayley Quinn
 Project Name
 Elevations

Project number CGT 262 Final Project
 Date 12/06/2019
 Drawn by Author
 Checked by Checker

A7

Scale 3/16" = 1'-0"

12/20/19 11:49:30 AM

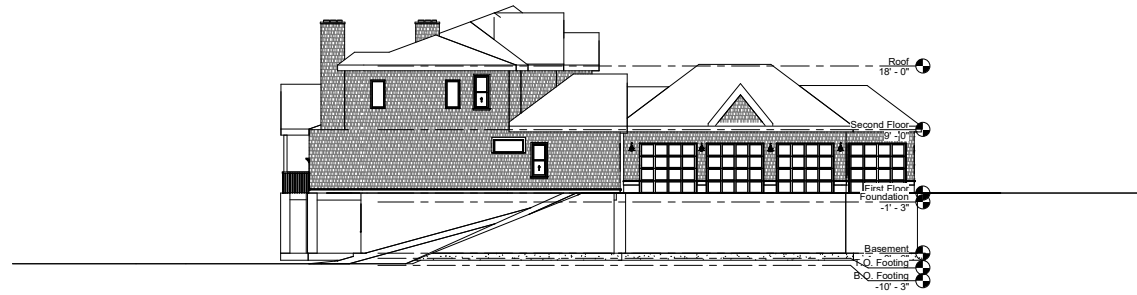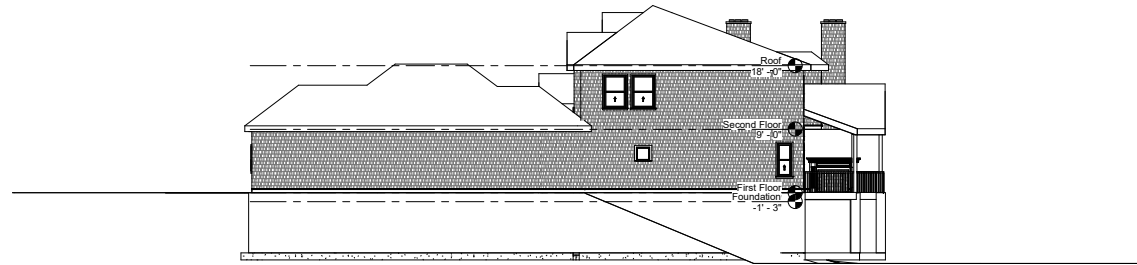

www.autodesk.com/revit

Consultant
Address
Address
Phone
Fax
e-mail

Consultant
Address
Address
Phone
Fax
e-mail

Consultant
Address
Address
Phone
Fax
e-mail

Consultant
Address
Address
Phone
Fax
e-mail

No.	Description	Date

Cayley Quinn
Project Name
Elevations

Project number: CGT 262 Final Project
Date: 12/06/2019
Drawn by: Author
Checked by: Checker

A8

Scale: 1/8" = 1'-0"



www.autodesk.com/revit

Consultant
Address
Phone
Fax
e-mail

Consultant
Address
Phone
Fax
e-mail

Consultant
Address
Phone
Fax
e-mail

Consultant
Address
Phone
Fax
e-mail


Consultant
Address
Phone
Fax
e-mail

No.	Description	Date



Cayley Quinn
Project Name
Basement Dimensions

Project number CGT 262 Final Project
Date 12/06/2019
Drawn by Author
Checked by Checker

A9
Scale 1/8" = 1'-0"

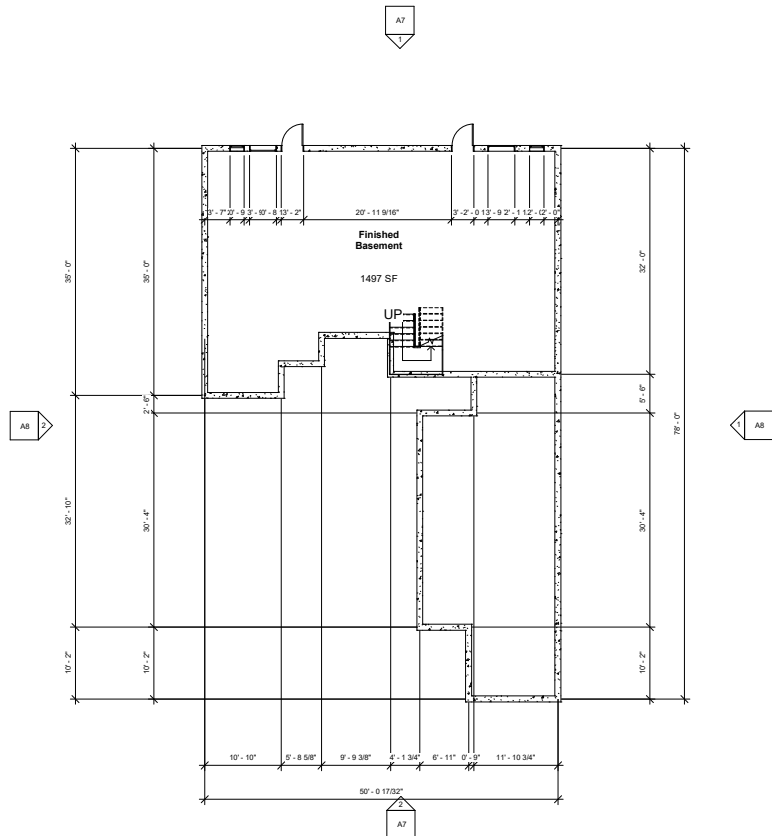

Cabinet Heights

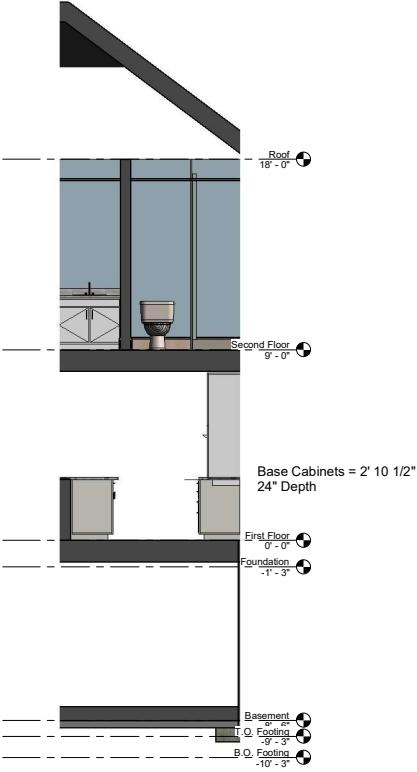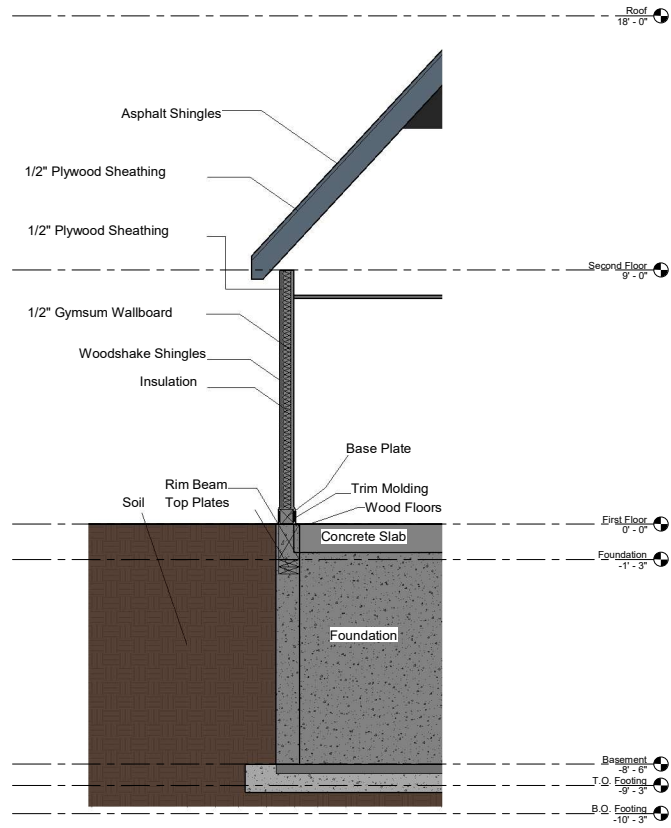

www.autodesk.com/revit

Consultant
Address
Phone
Fax
e-mail

Consultant
Address
Phone
Fax
e-mail

Consultant
Address
Phone
Fax
e-mail

Consultant
Address
Phone
Fax
e-mail

Consultant
Address
Phone
Fax
e-mail

No.	Description	Date

Cayley Quinn
Project Name
Wall Sections

Project number: CGT 262 Final Project
Date: 12/06/2019
Drawn by: Author
Checked by: Checker
A10
Scale: As indicated

12/06/2019 11:49:33 AM

Door Schedule														
Door Number	Door Type	Door Size	Manufacturer	Model	Frame Type	Fire Rating	Details			Description	Door	Frame	Finish	
							Head	Jamb	Sill					Comments
	115	Door-Curtain-Wall-Single-Glass												
1	67	32" x 80"												
2	67	32" x 80"												
3	67	32" x 80"												
4	61	20" x 80"												
5	61	20" x 80"												
6	66	30" x 80"												
7	111	36" x 84"												
8	112	96" x 84"												
9	112	96" x 84"												
10	112	96" x 84"												
12	111	36" x 84"												
14	68	34" x 80"												
15	77	26" x 84"												
16	68	34" x 80"												
17	112	96" x 84"												
18	66	30" x 80"												
20	66	30" x 80"												
21	64	26" x 80"												
22	66	30" x 80"												
23	54	48" x 80"												
24	52	60" x 84"												
25	52	60" x 84"												
26	52	60" x 84"												
27	38	30" x 80"												
28	43	30" x 80"												
30	35	34" x 84"												
36	111	36" x 84"												
37	111	36" x 84"												

Window Schedule														
Type Mark	Rough Opening		Type	Manufacturer	Model	Material	Finish	Detail			Glazing		Head Height	Comments
	Width	Height						Head	Jamb	Sill	Thickness	Type		
46	4' - 6"	4' - 9"	Fixed with Trim											
48	2' - 0"	2' - 0"	Fixed with Trim										6' - 6 3/32"	
53	4' - 4"	2' - 0"	Fixed with Trim											
66	2' - 0"	4' - 0"	Window-Double-Hung-Arch-Head											
84	2' - 0"	4' - 8"	Window-Single-Hung											
89	3' - 2"	4' - 8"	Window-Single-Hung										7' - 8"	
92	2' - 0"	2' - 0"	Window-Fixed-Quarter-Round											
96		4' - 0"	Instance-Window-Fixed										7' - 0"	

Lighting Fixture Schedule					
Type Mark	Family and Type	Manufacturer	Model	Lamp	Type Comments
	Ceiling Light - Linear Box 1x4(2 Lamp) - 277V			T-12	
	Downlight - Under Cabinet 277V			T-8	
	Floor Lamp - Torchiere 120V			T-4	
	Wall Lamp - Bracket 100W - 120V			A-19	

Room Finish Schedule							
Room Number	Room Name	Finish					Comments
		Floor	Base	Wall	Ceiling	Ceiling Height	
1	Master Bedroom						
2	Room						
3	Toilet Room						
4	Master Walk-in Closet						
5	Room						
6	1/2 Bath						
7	Great Room						
8	Dining Room						
9	Kitchen						
10	Foyer						
11	Laundry Room						
12	Garage						
13	Finished Basement						
14	Bedroom 2						
15	Room						
16	Bedroom 3						
17	Bathroom 2						
18	Bedroom 4						
19	Bathroom 3/4						



www.autodesk.com/revit

Consultant
Address
Phone
Fax
e-mail

Consultant
Address
Phone
Fax
e-mail

Consultant
Address
Phone
Fax
e-mail

Consultant
Address
Phone
Fax
e-mail

Consultant
Address
Phone
Fax
e-mail


No.	Description	Date

Cayley Quinn
Project Name
Schedules

Project number: CGT 262 Final Project
Date: 12/06/2019
Drawn by: Author
Checked by: Checker

A11

Scale: _____

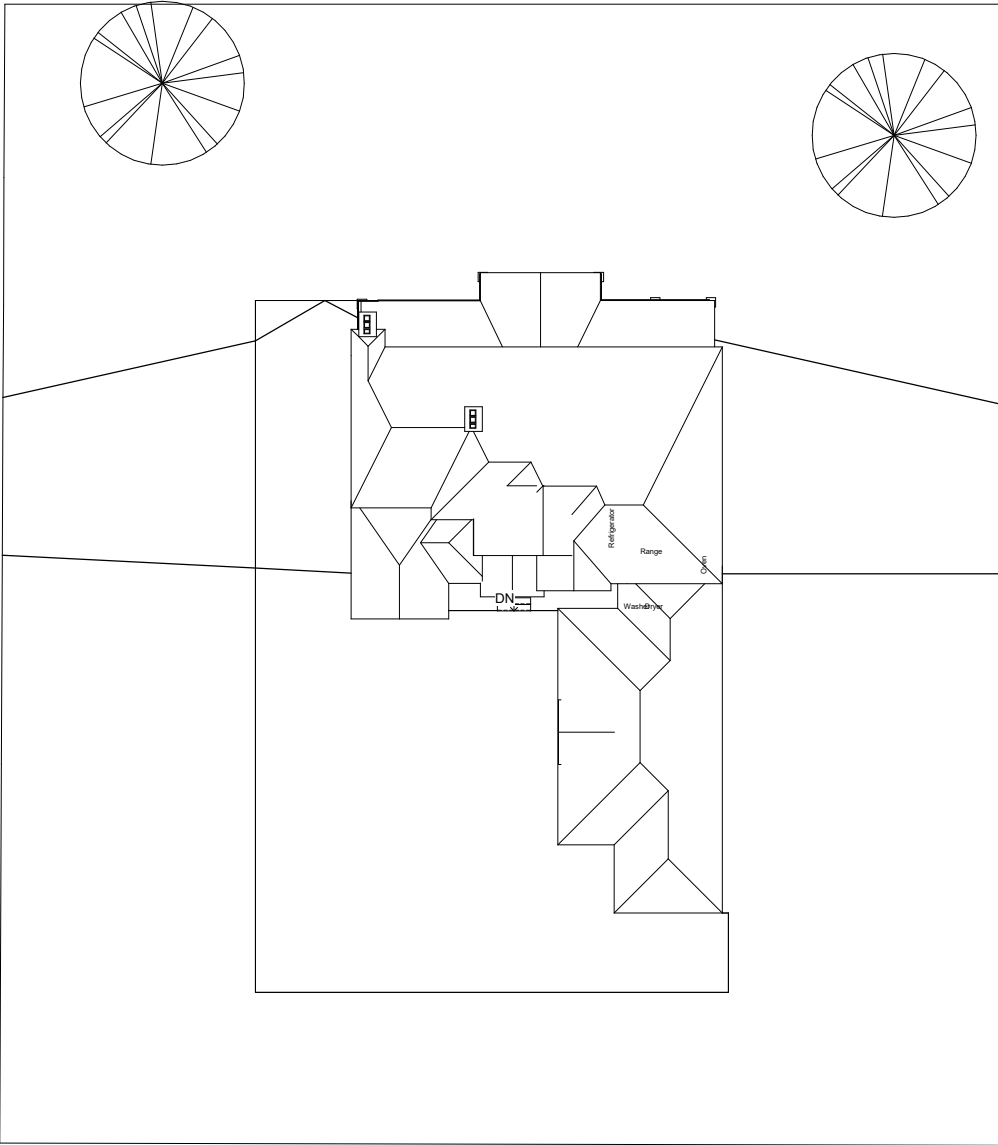

Site Plan
1/8" = 1'-0"



www.autodesk.com/revit

Consultant
Address
Phone
Fax
e-mail

Consultant
Address
Phone
Fax
e-mail

Consultant
Address
Phone
Fax
e-mail

Consultant
Address
Phone
Fax
e-mail

Consultant
Address
Phone
Fax
e-mail

No.	Description	Date

Cayley Quinn
Project Name
Site Plan

Project number CGT 262 Final Project


Date 12/06/2019

Drawn by Author

Checked by Checker

A12

Scale 1/8" = 1'-0"

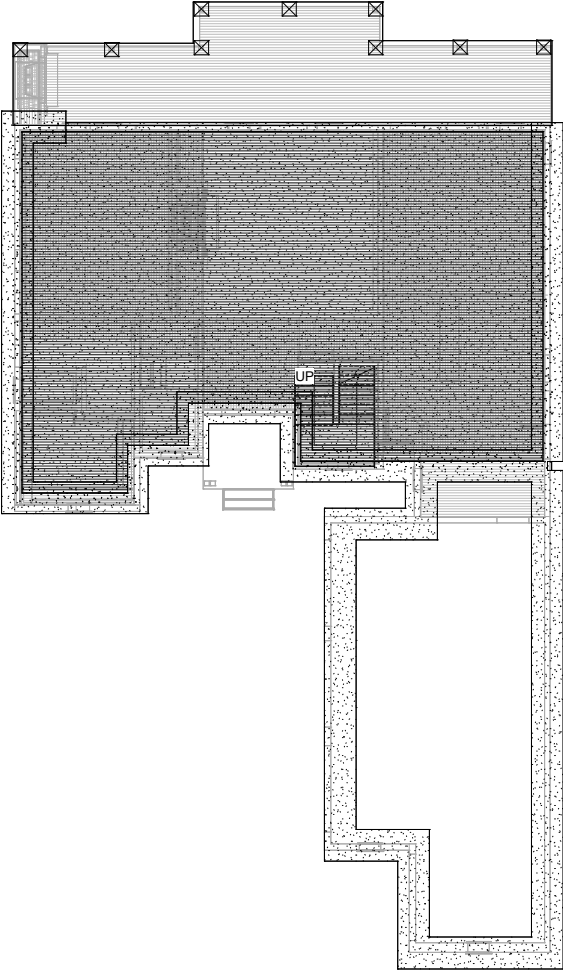

www.autodesk.com/revit

Consultant
Address
Phone
Fax
e-mail

Consultant
Address
Address
Phone
Fax
e-mail

Consultant
Address
Address
Phone
Fax
e-mail

Consultant
Address
Address
Phone
Fax
e-mail

Consultant
Address
Address
Phone
Fax
e-mail

No.	Description	Date

Cayley Quinn
Project Name
Foundation Plan

Project number CGT 262 Final Project

Date 12/06/2019

Drawn by Author

Checked by Checker

A13

Scale 3/16" = 1'-0"

12/30/19 11:49:35 AM